


**GROUND FLOOR FAR**

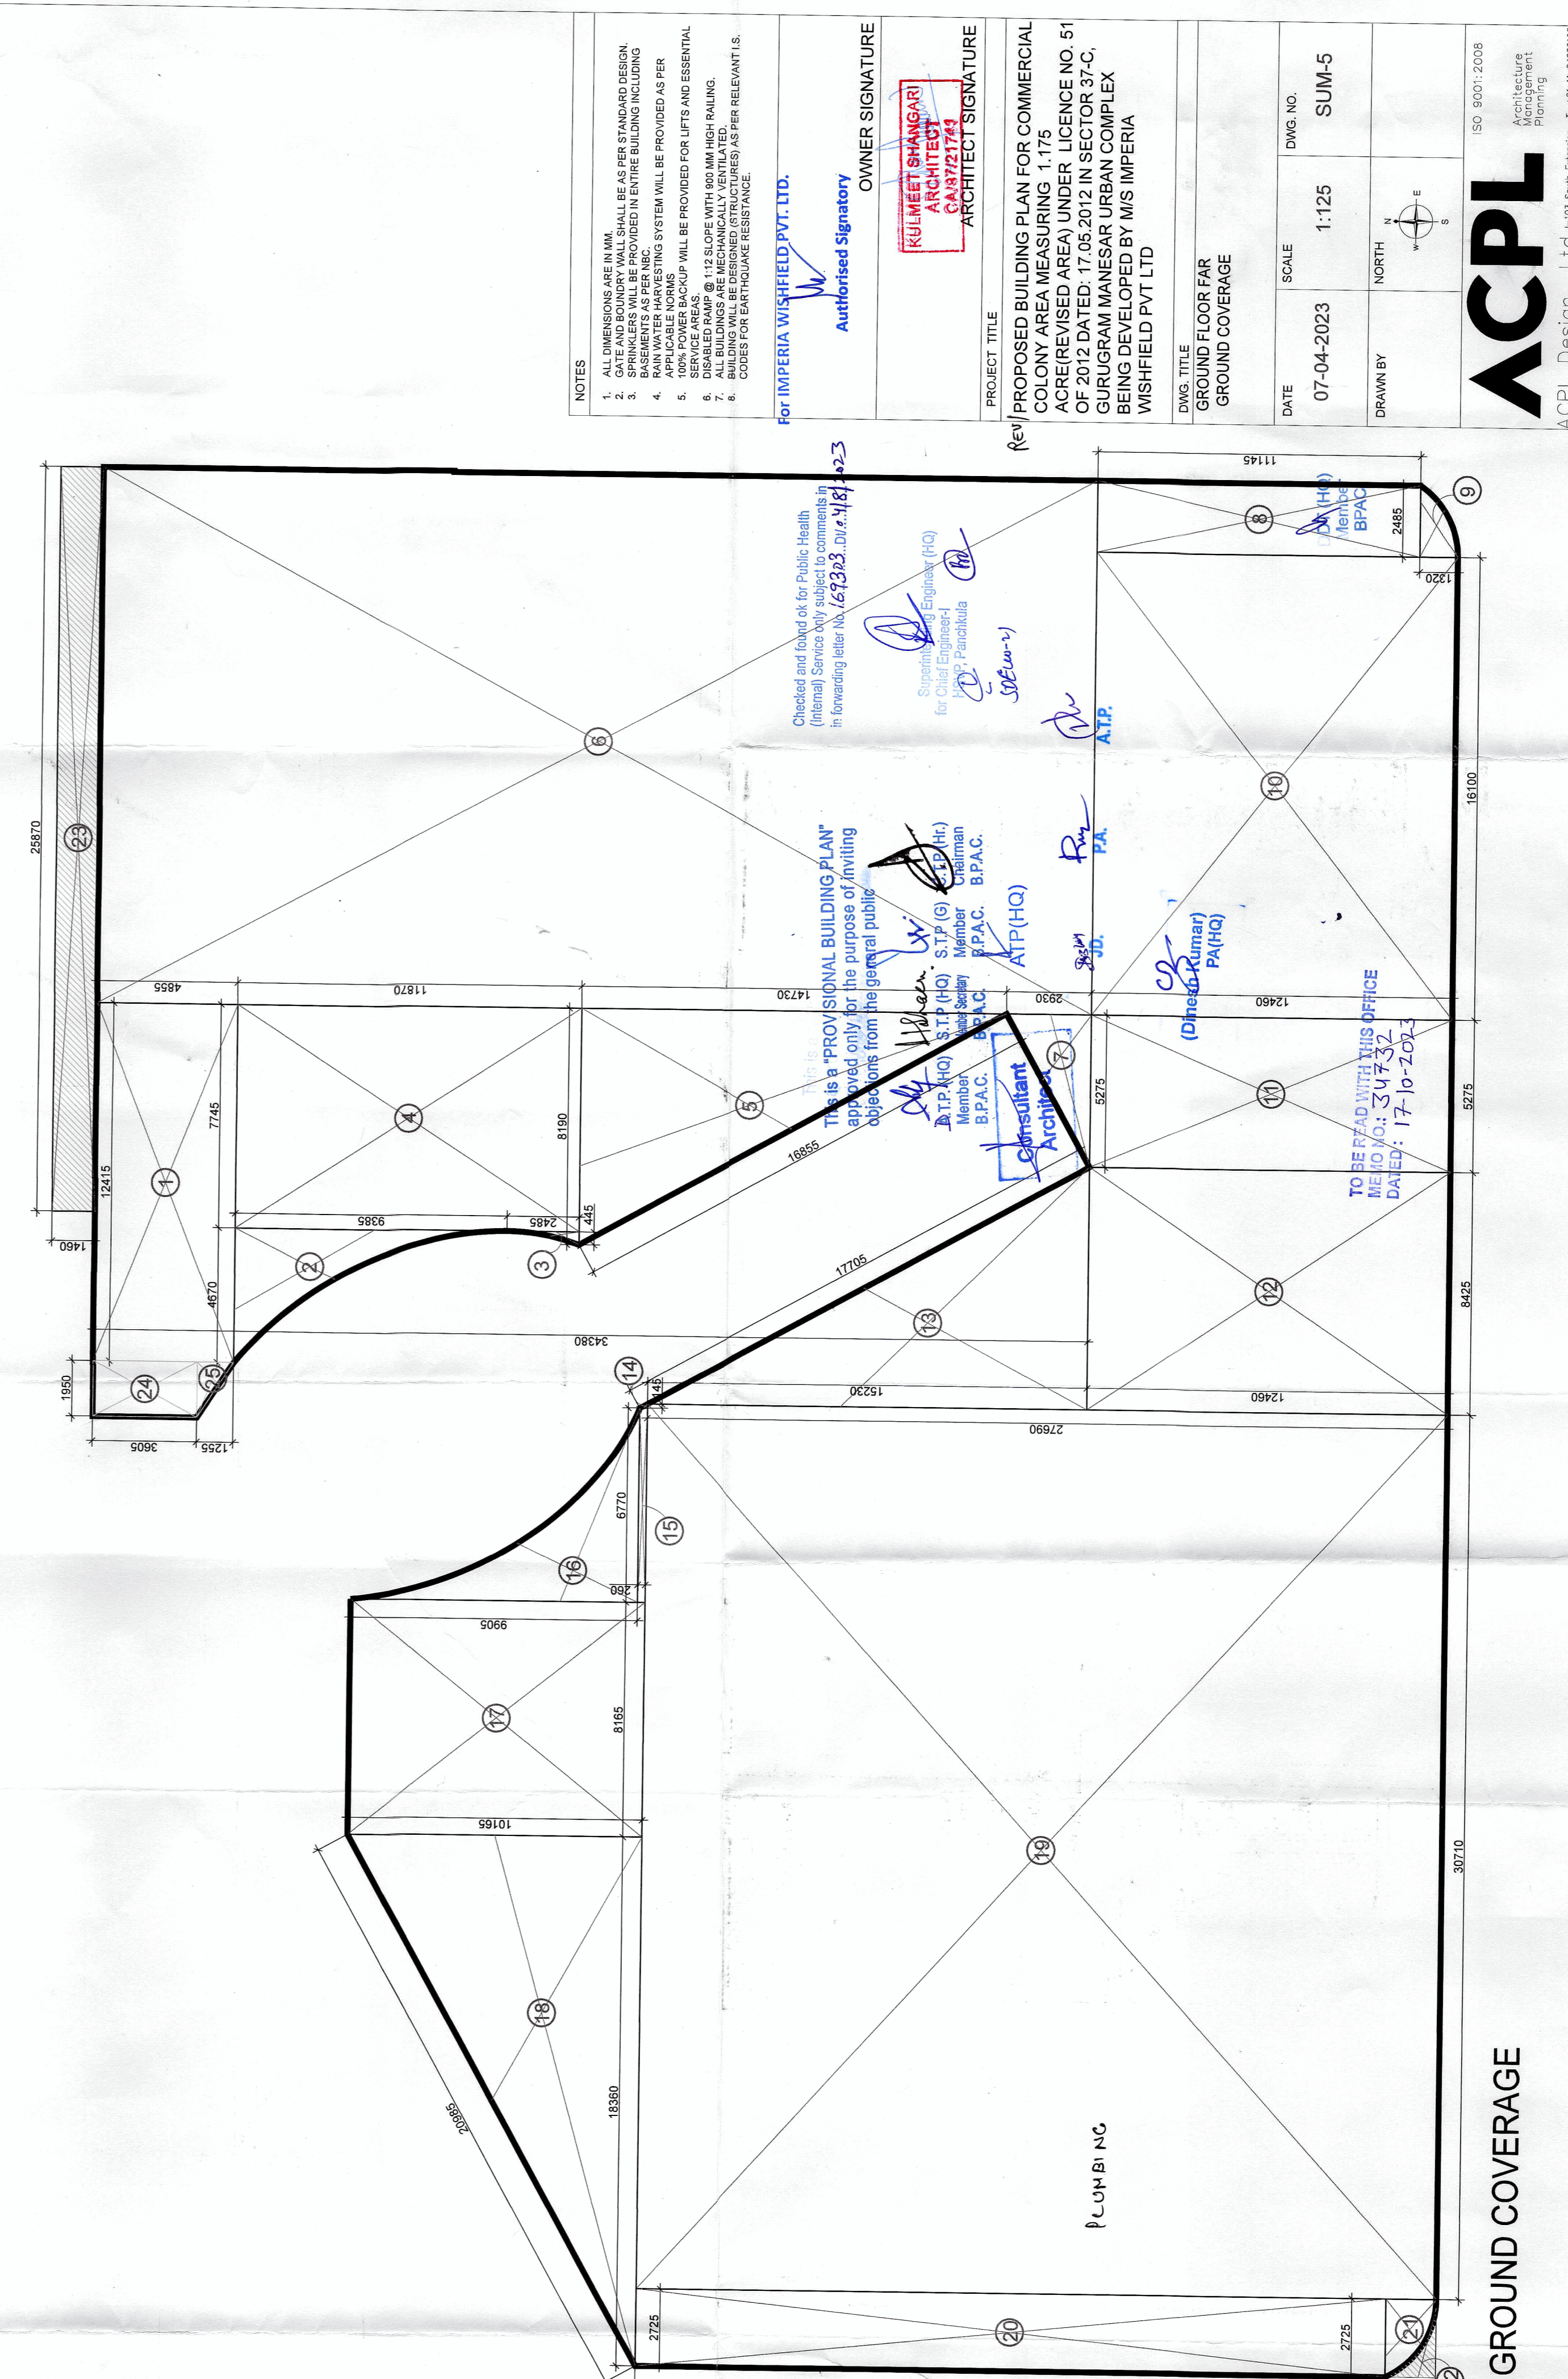

**GROUND COVERAGE**

**NOTES**



1. ALL DIMENSIONS ARE IN METERS, UNLESS OTHERWISE SPECIFIED.
2. THE PROPOSED BUILDING SHALL BE AS PER PLANNING DEPARTMENT APPROVED DRAWINGS.
3. THE PROPOSED BUILDING SHALL BE IN ACCORDANCE WITH THE APPLICABLE ZONING REGULATIONS.
4. THE PROPOSED BUILDING SHALL BE PROVIDED AS PER THE APPLICABLE ZONING REGULATIONS.
5. THE PROPOSED BUILDING SHALL BE PROVIDED AS PER THE APPLICABLE ZONING REGULATIONS.
6. THE PROPOSED BUILDING SHALL BE PROVIDED AS PER THE APPLICABLE ZONING REGULATIONS.
7. THE PROPOSED BUILDING SHALL BE PROVIDED AS PER THE APPLICABLE ZONING REGULATIONS.
8. THE PROPOSED BUILDING SHALL BE PROVIDED AS PER THE APPLICABLE ZONING REGULATIONS.
9. THE PROPOSED BUILDING SHALL BE PROVIDED AS PER THE APPLICABLE ZONING REGULATIONS.
10. THE PROPOSED BUILDING SHALL BE PROVIDED AS PER THE APPLICABLE ZONING REGULATIONS.

**PROJECT TITLE:** PROPOSED BUILDING PLAN FOR COMMERCIAL COLONY AREA MEASURING 1.175 ACRES IN SECTOR 37-C, GURUGRAM MUNICIPAL CORPORATION, Haryana.

**OWNER SIGNATURE:** *[Signature]*  
**ARCHITECT SIGNATURE:** *[Signature]*

**DATE:** 07-04-2023  
**SCALE:** 1:25  
**DWG. NO.:** SUM-5  
**DRAWN BY:** NORTH

**ACPL**

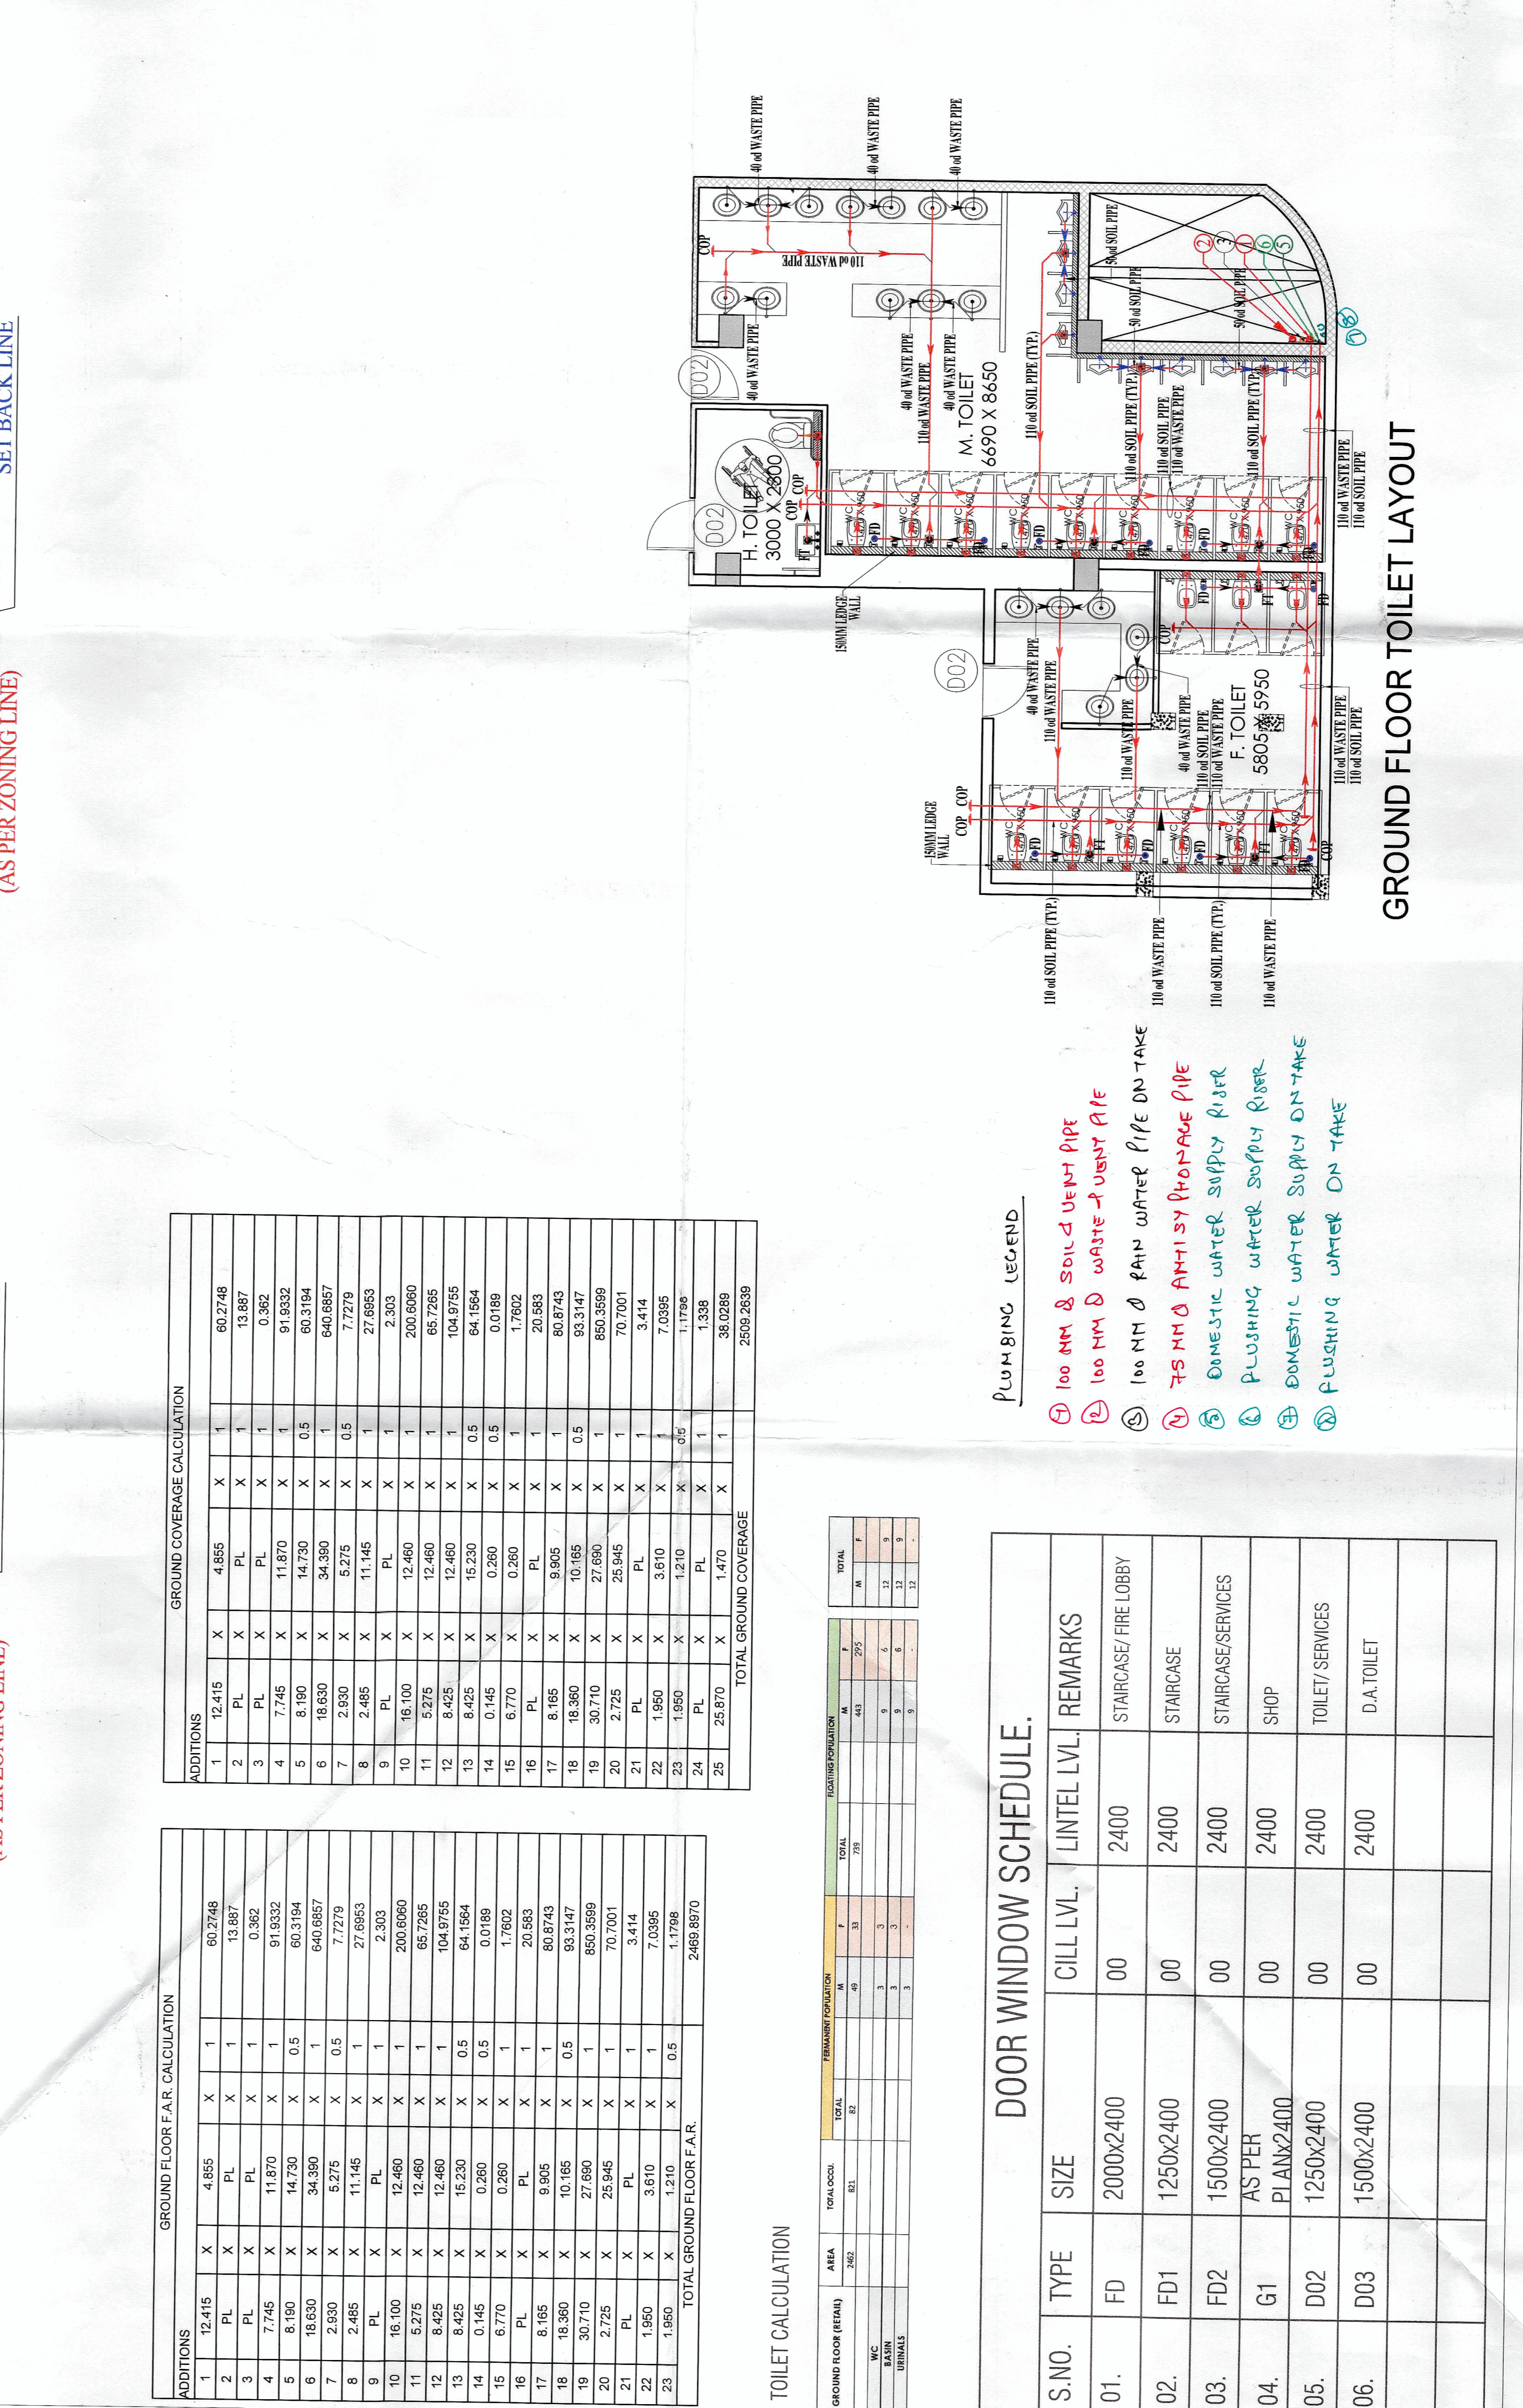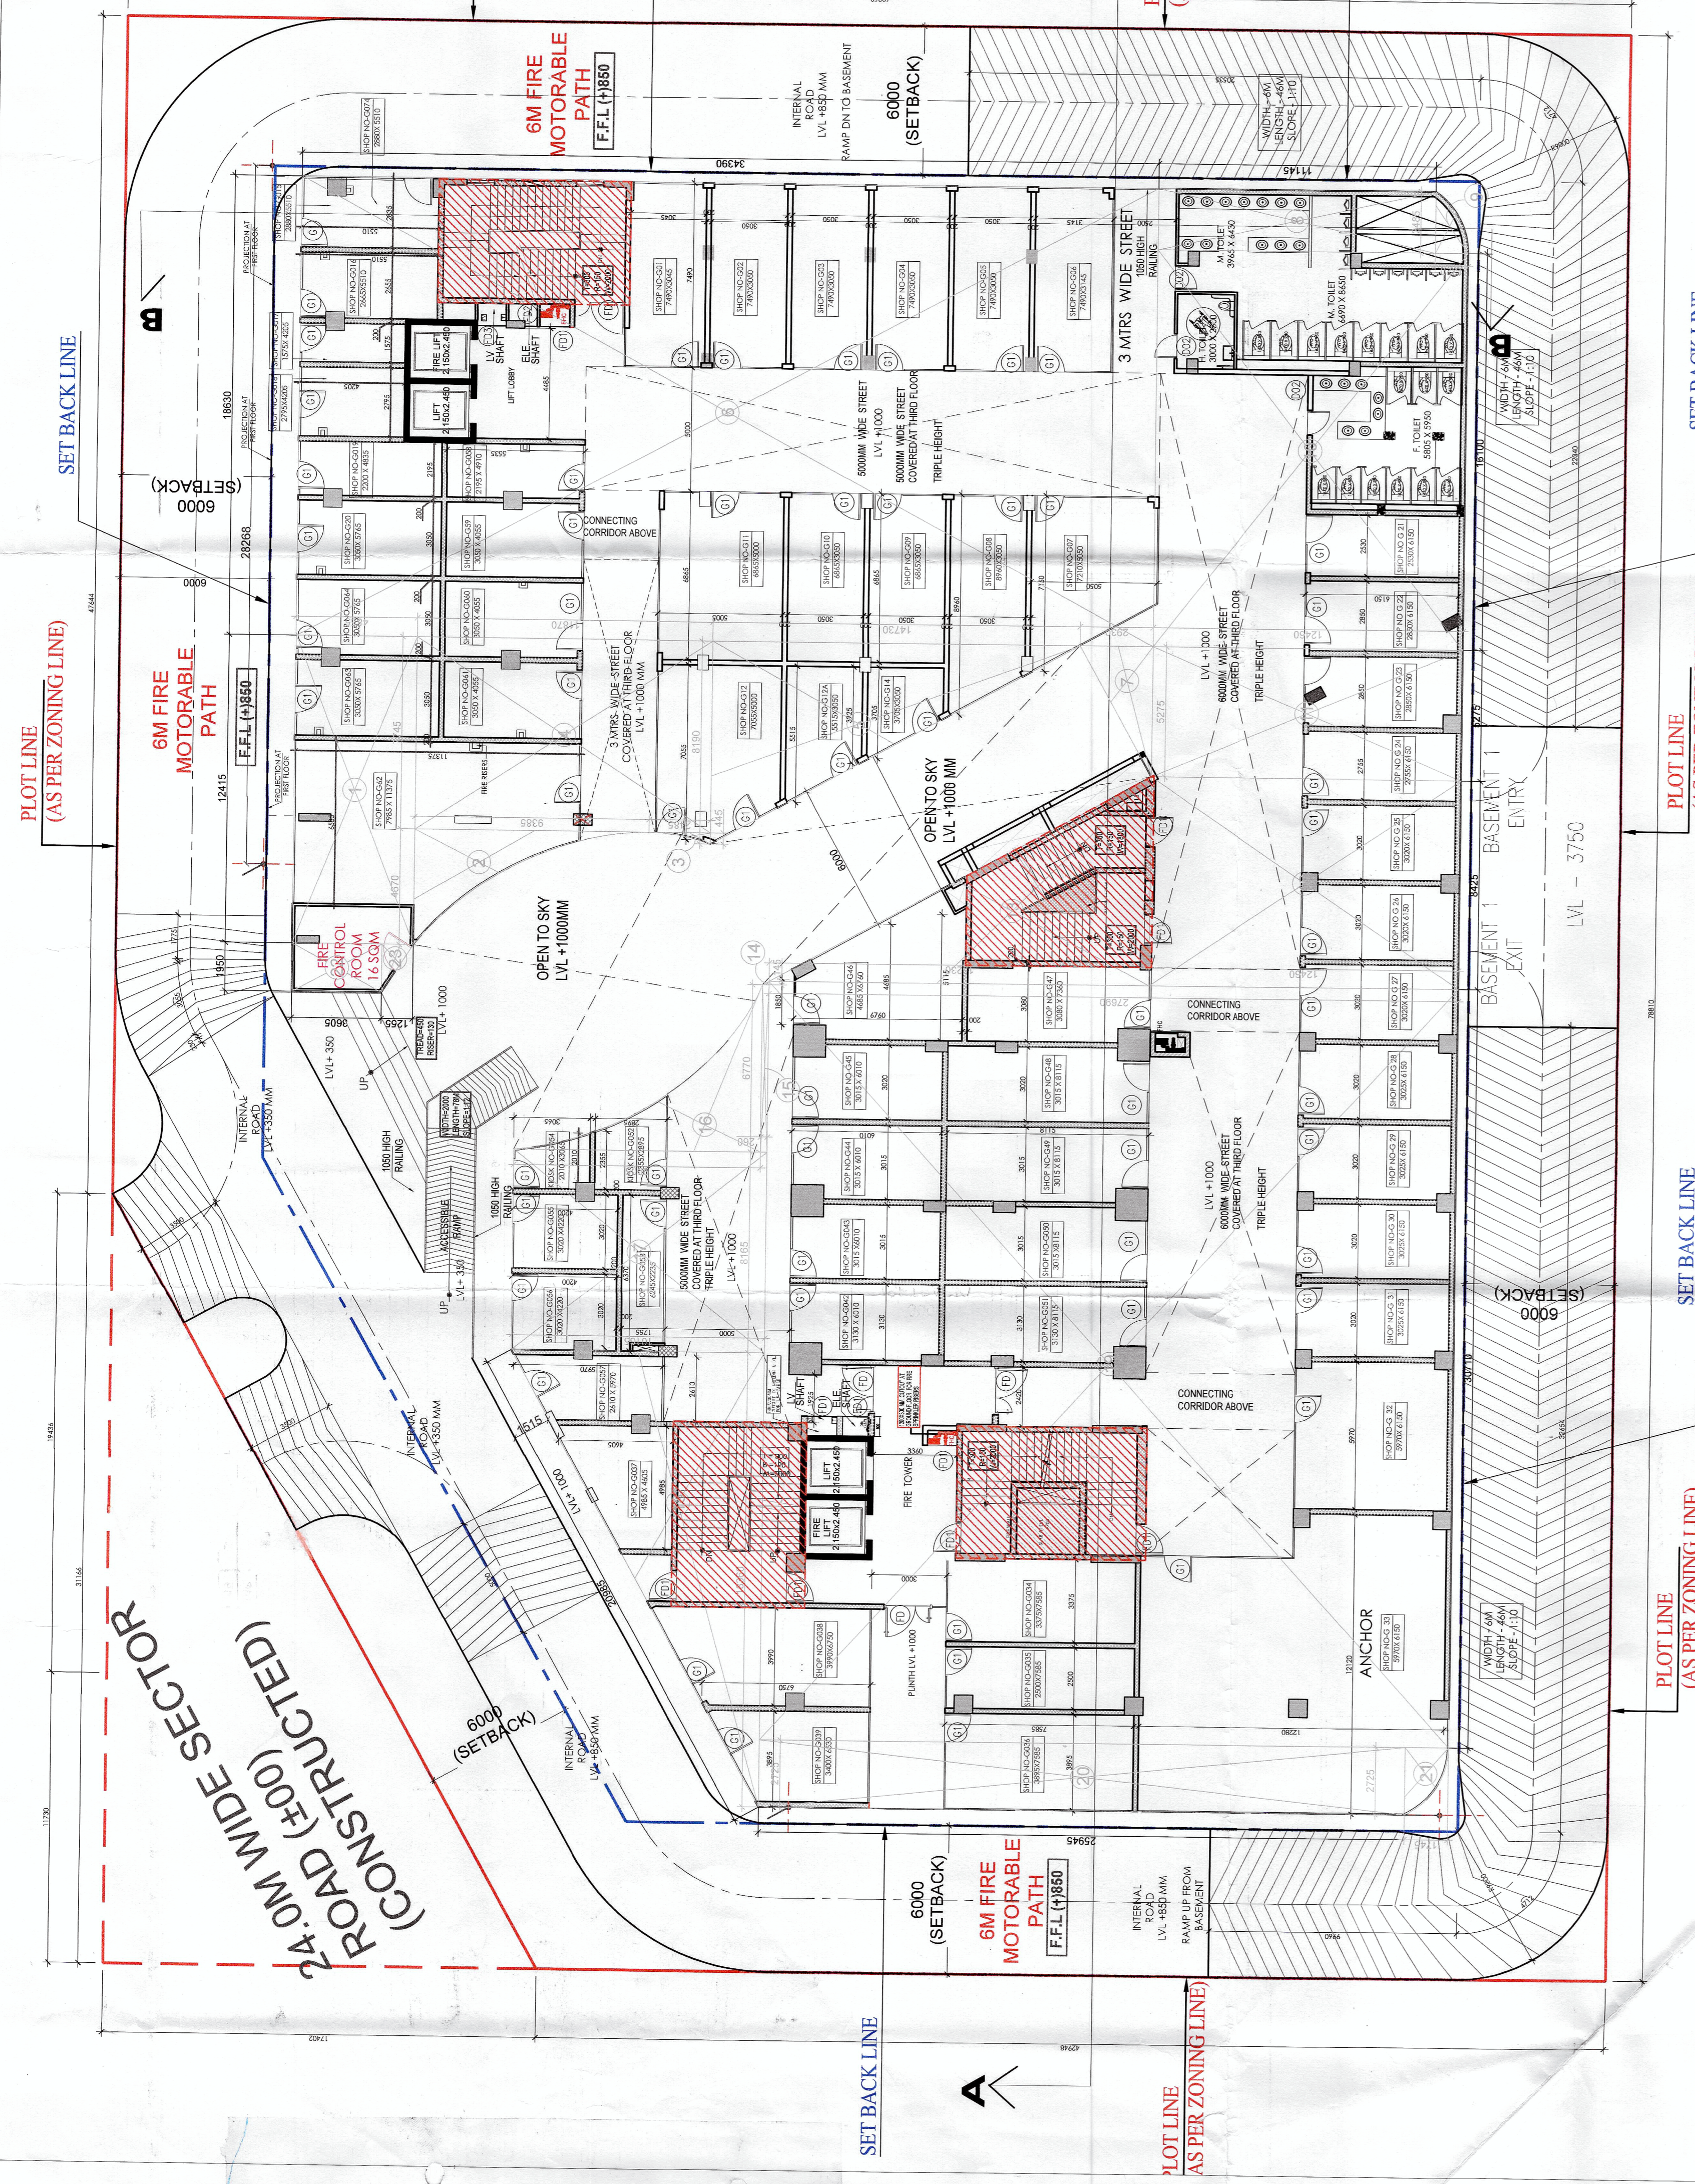

ADDITIONS	GROUND FLOOR F.A.E. CALCULATION	TOILET CALCULATION
1	12.415	1
2	13.817	2
3	11.870	3
4	14.730	4
5	9.132	5
6	14.730	6
7	14.730	7
8	2.500	8
9	11.145	9
10	12.460	10
11	12.460	11
12	12.460	12
100	12.460	100

- PLUMBING LEGEND**
- 100 MM & SOLID WASTE PIPE
  - 100 MM WASTE & WATER PIPE
  - 75 MM & 75 MM WATER PIPE
  - DOMESTIC WATER SUPPLY PIPE
  - PLUMBING WATER SUPPLY PIPE
  - DOMESTIC WATER SUPPLY ON-TIME
  - PLUMBING WATER ON-TIME

**TOILET CALCULATION**

S.NO.	TYPE	SIZE	CILL LVL.	LINTEL LVL.	REMARKS
01.	FD	2000x2400	00	2400	STAIRCASE/FIRE LOBBY
02.	FD1	1250x2400	00	2400	STAIRCASE
03.	FD2	1500x2400	00	2400	STAIRCASE/SERVICES
04.	G1	AS/PER PLANS	00	2400	SHOP
05.	D02	1250x2400	00	2400	TOILET/SERVICES
06.	D03	1500x2400	00	2400	D.A TOILET

**DOOR WINDOW SCHEDULE.**